



SEE SHEET 8

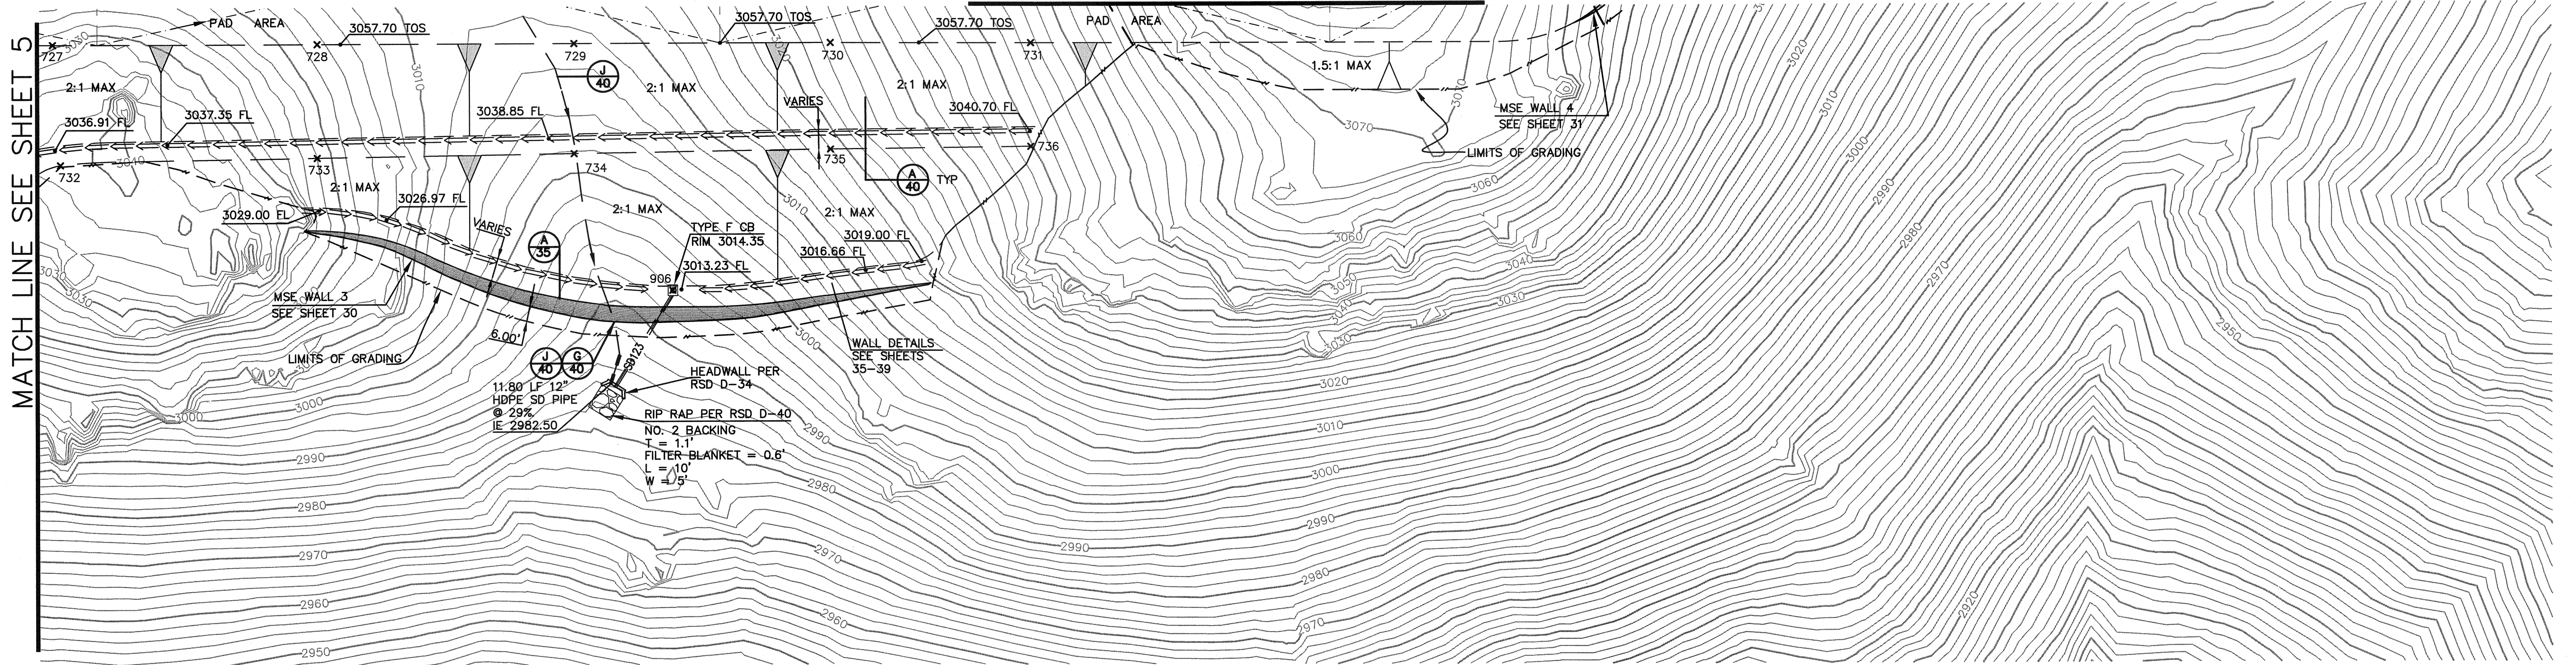

MATCH LINE SEE SHEET 5

SEE SHEET 5

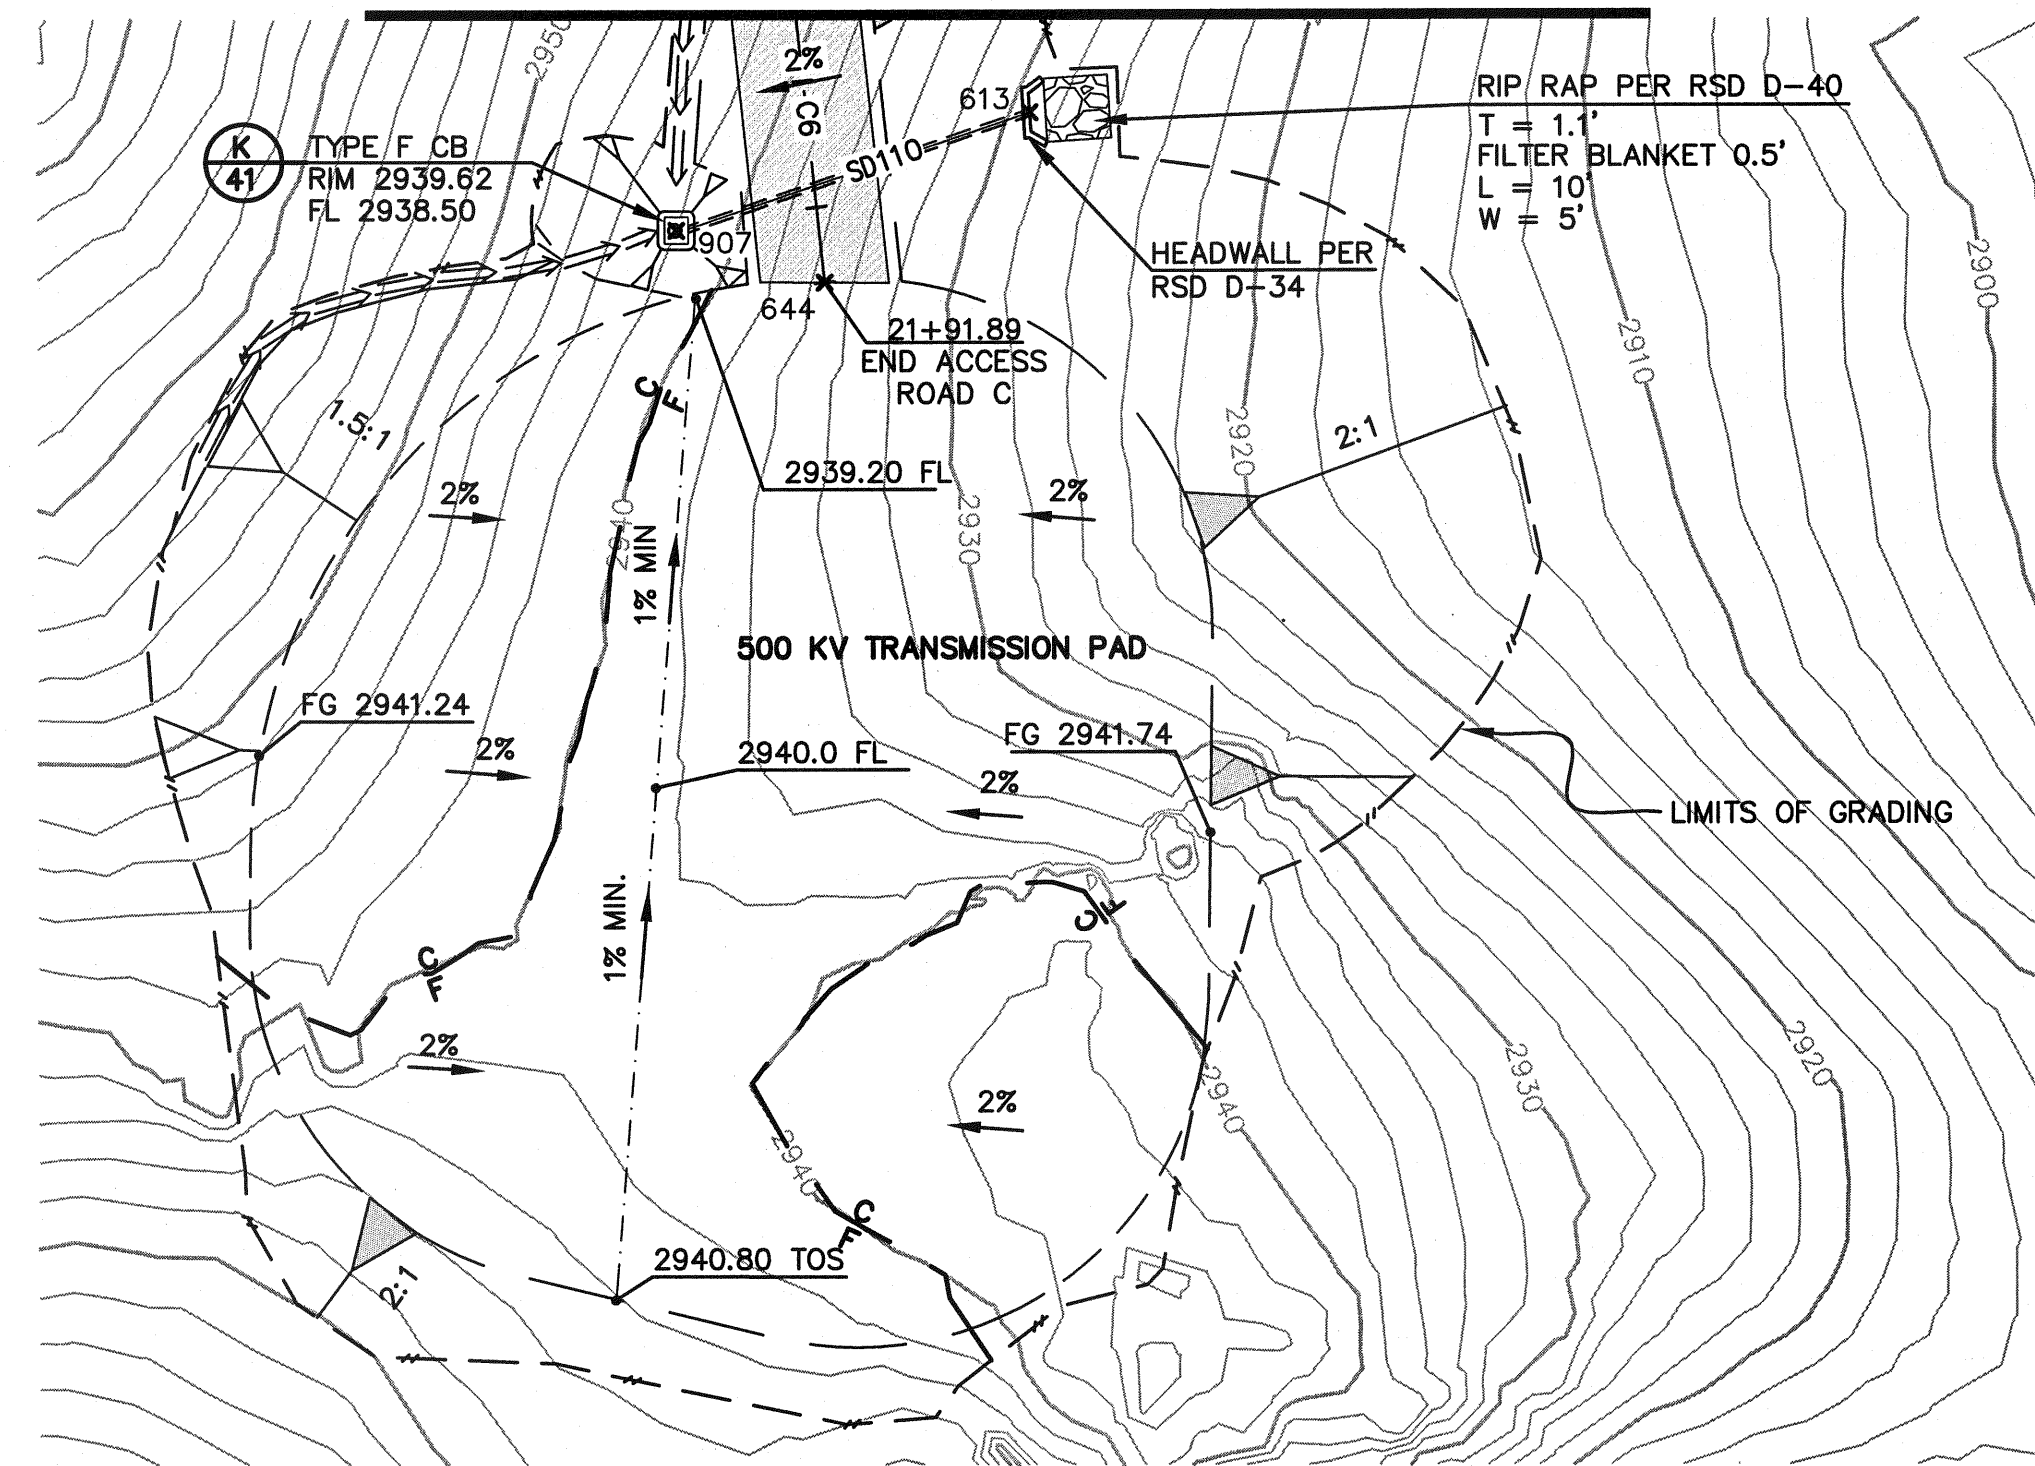

× CENTER POINT
STORM DRAIN BOX DATA TABLE

POINT #	NORTHING	EASTING	REMARKS
906	1873343.2396	6428728.1270	CP SD BOX
907	1873000.6682	6428230.2096	CP SD BOX

ROAD C CENTERLINE DATA TABLE

SYMBOL	DELTA/BEARING	RADIUS	LENGTH	REMARKS
C6	N06°00'00"W	...	54.92'	...




STORMDRAIN DATA TABLE

SYMBOL	DELTA/BEARING	RADIUS	LENGTH	REMARKS
SD110	N71°03'48"E	...	57.12'	12" HDPE
SD123	N31°59'33"E	...	42.39'	12" HDPE

NOTE: ALL STORM DRAIN LENGTHS ARE MEASURED ALONG PIPE CENTERLINE FROM INSIDE FACE TO INSIDE FACE ON CONCRETE STRUCTURE OR TO TERMINATION POINT AT CONCRETE HEADWALL. TABLE LENGTHS REPRESENT TOTAL PIPE LENGTH WHERE PIPES ARE SHOWN ON TWO PLAN SHEETS.

× POINT DATA TABLE

POINT #	NORTHING	EASTING	REMARKS
613	1873019.2047	6428285.4673	SD CL
644	1872992.4902	6428253.3592	CL RD C
727	1873439.9051	6428486.6798	TOP SLOPE
728	1873439.9051	6428589.7512	TOP SLOPE
729	1873439.9051	6428689.7512	TOP SLOPE
730	1873439.9051	6428789.7512	TOP SLOPE
731	1873439.9051	6428867.6638	TOP SLOPE
732	1873392.9376	6428489.7063	TOP SLOPE
733	1873395.4720	6428589.6962	TOP SLOPE
734	1873396.9098	6428689.7512	TOP SLOPE
735	1873398.3468	6428789.7512	TOP SLOPE
736	1873399.4664	6428867.6638	TOP SLOPE

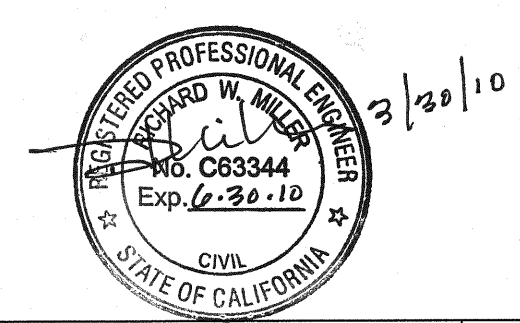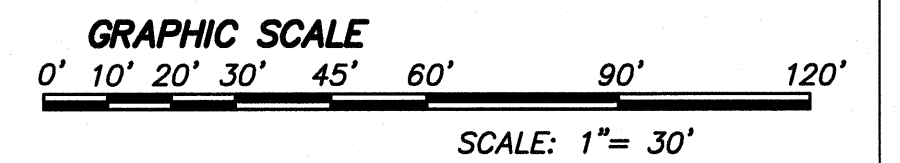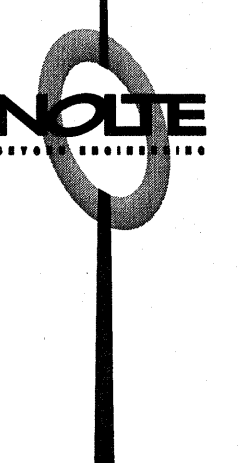

REVISIONS

NO.	WORK DONE	DATE:	BY:	APP'D:	NO.	WORK DONE	DATE:	BY:	APP'D:	NO.	WORK DONE	DATE:	BY:	APP'D:	NO.	WORK DONE	DATE:	BY:	APP'D:	NO.	

SAN DIEGO GAS & ELECTRIC COMPANY
SAN DIEGO, CALIFORNIA

SUNCREST SUBSTATION
GRADING PLAN

DRAWN BY: MJ DATE: 3/24/10 SCALE: 1"=30' W.D.: - REV.: 0
 CHECKED BY: RWM DATE: -
 APPROVED BY: CR DATE: - SHEET 6 OF 66
 CAD NO.: GPO6 PLOT SCALE: 1=1

SCR-C-006

